
 


1 2 3 4 5 6

A  
B  
C  
D

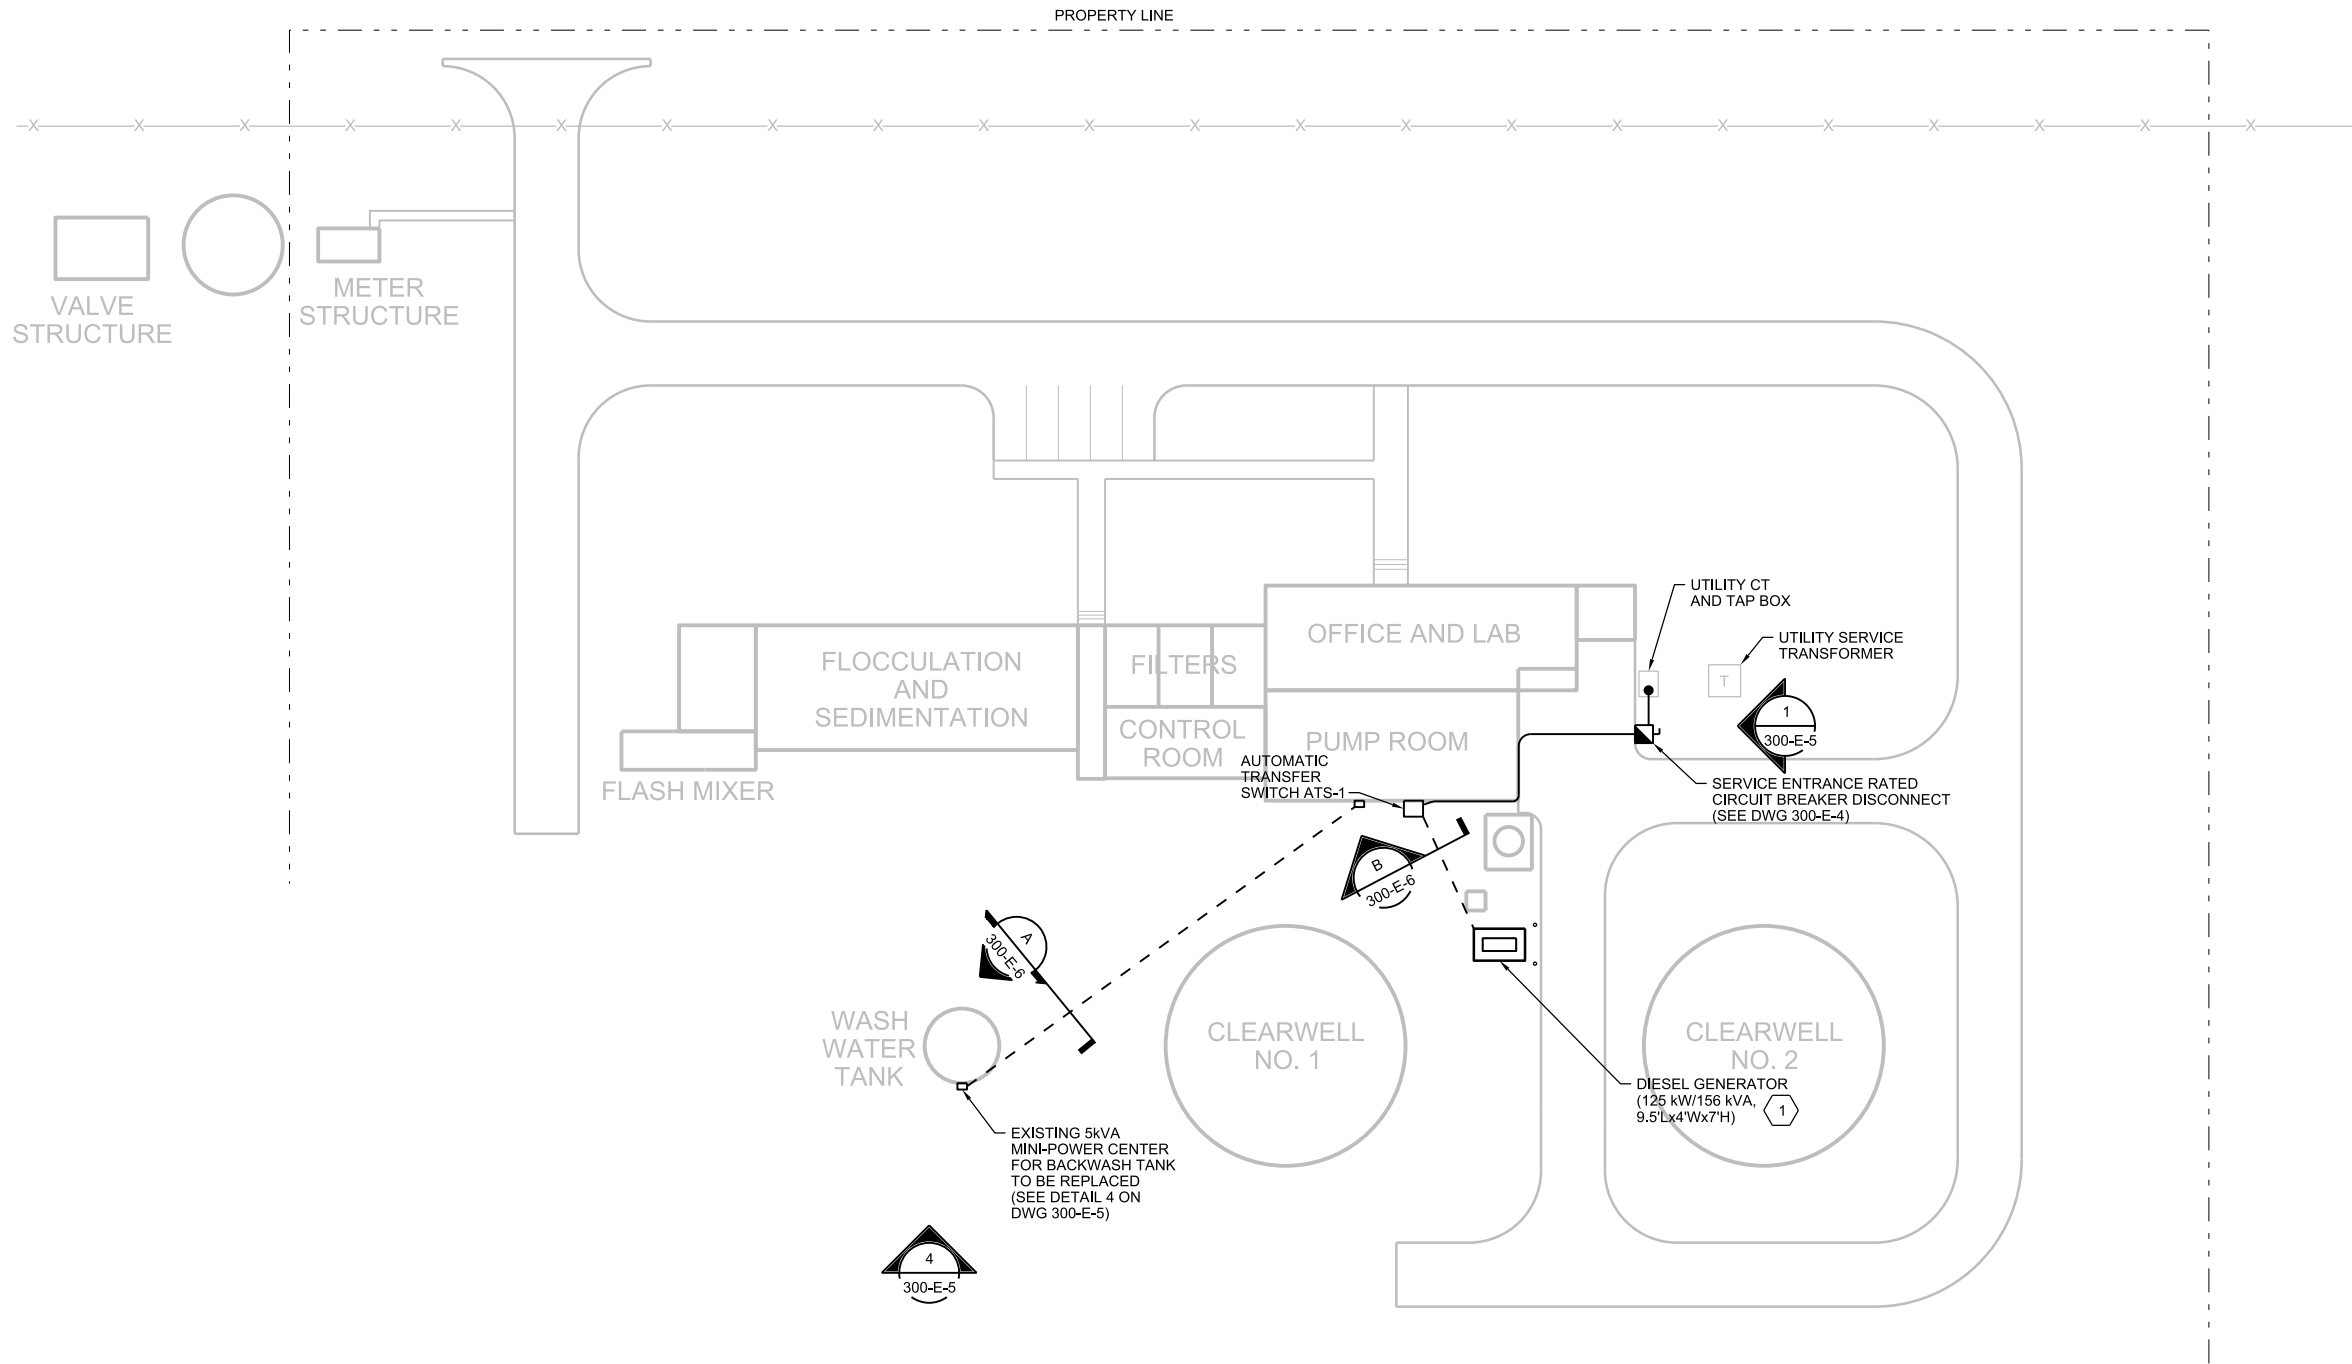

**SITE PLAN**  
1"=30'-0"



- GENERAL NOTES:**
- REF DWG 300-E-4 FOR POWER DISTRIBUTION REQUIREMENTS.
- KEYED NOTES:**
- 1 VERIFY EXACT CONDUIT STUBUP LOCATION AT GENERATOR WITH APPROVED GENERATOR SHOP DRAWINGS PRIOR TO CONDUIT INSTALLATION. SEE DWG 300-E-6 FOR GROUNDING DETAILS.

NO.	DATE	DR	CHK	APVD	BY	APVD	S HO
				J MORAN			
				J OCONNOR			

**CH2M Hill Engineers, Inc.**  
TBPE FIRM NO. 3699

Wastewater Treatment Plant  
Water Treatment Plant and Prison Lift Station  
Improvements  
City of Pampa, Texas

**ch2m**

WTP ELECTRICAL  
**SITE PLAN**

AS NOTED  
VERIFY SCALE  
BAR IS ONE INCH ON ORIGINAL DRAWING.  
DATE MARCH 2016  
PROJ 659681  
DWG 300-E-1  
SHEET 83 of 125

TENDER / BID DOCUMENTS

©CH2M HILL 2014. ALL RIGHTS RESERVED.